



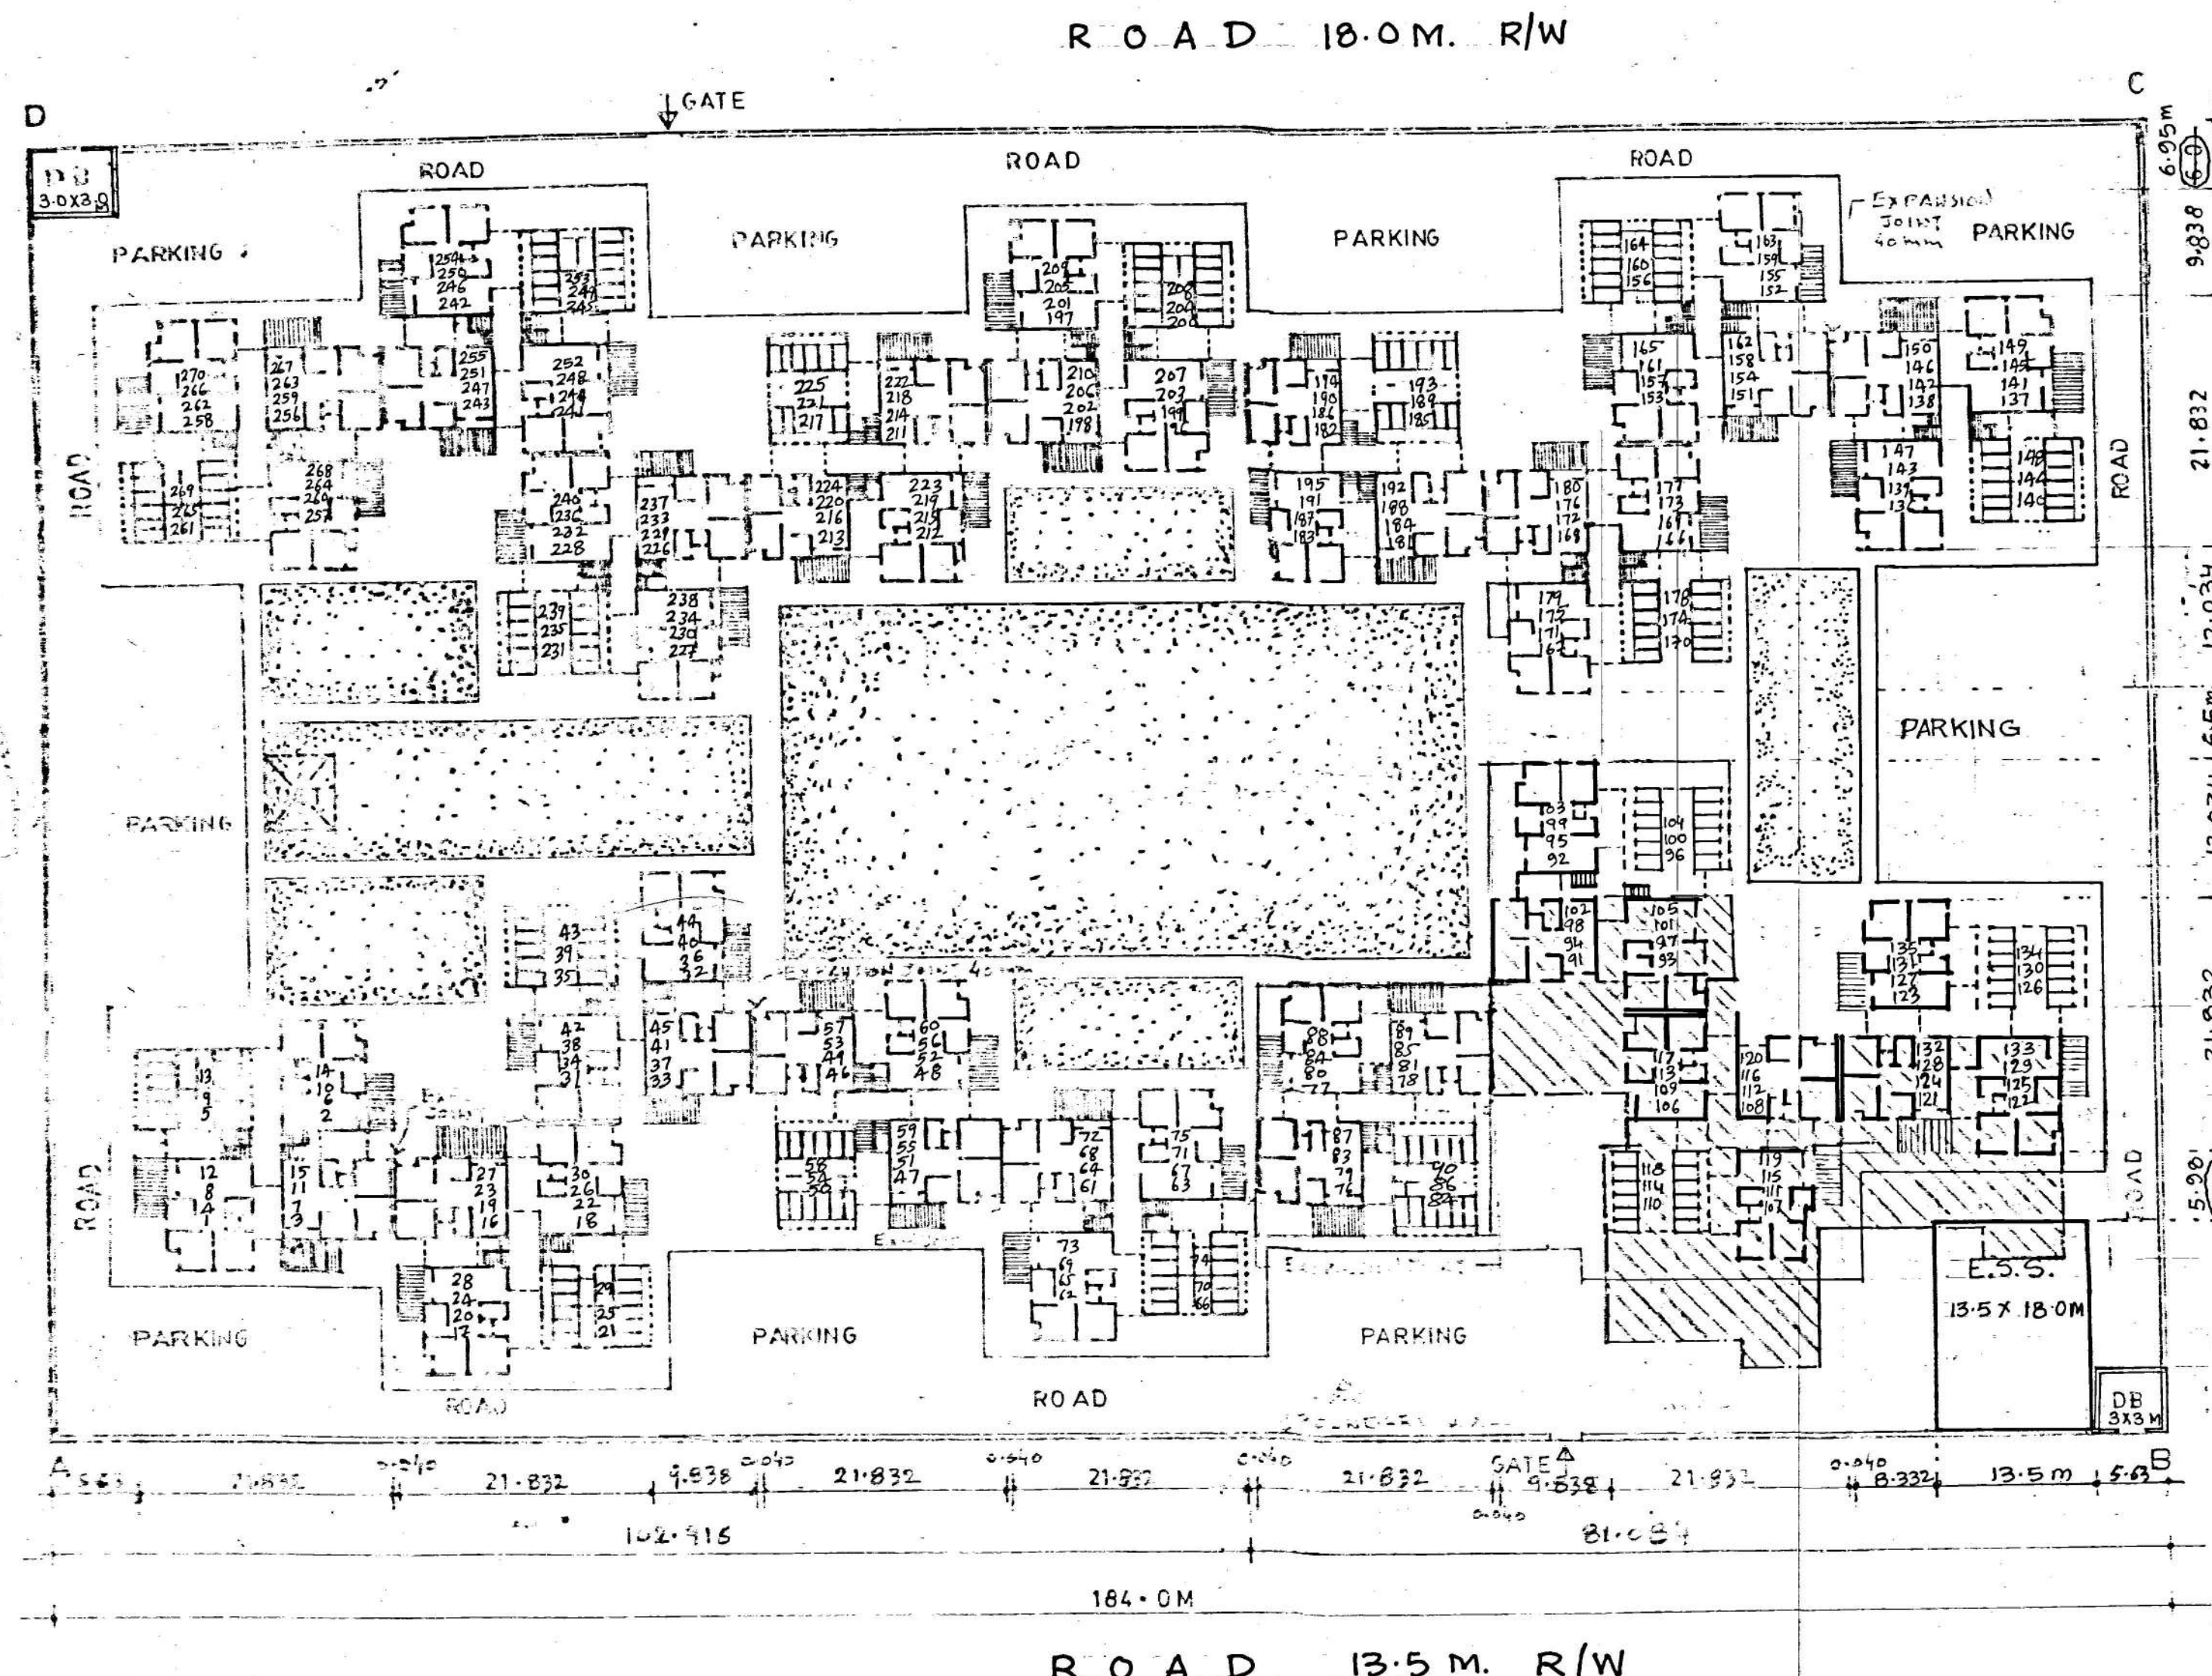

LAYOUT PLAN FOR SECT. 21 PKT.-7

SCALE 1:500
POCKET AREA : 2.1 HAC.
NO. OF DUS : 270
UNIT DESIGN NO. : 75
NO. OF ST. : 4

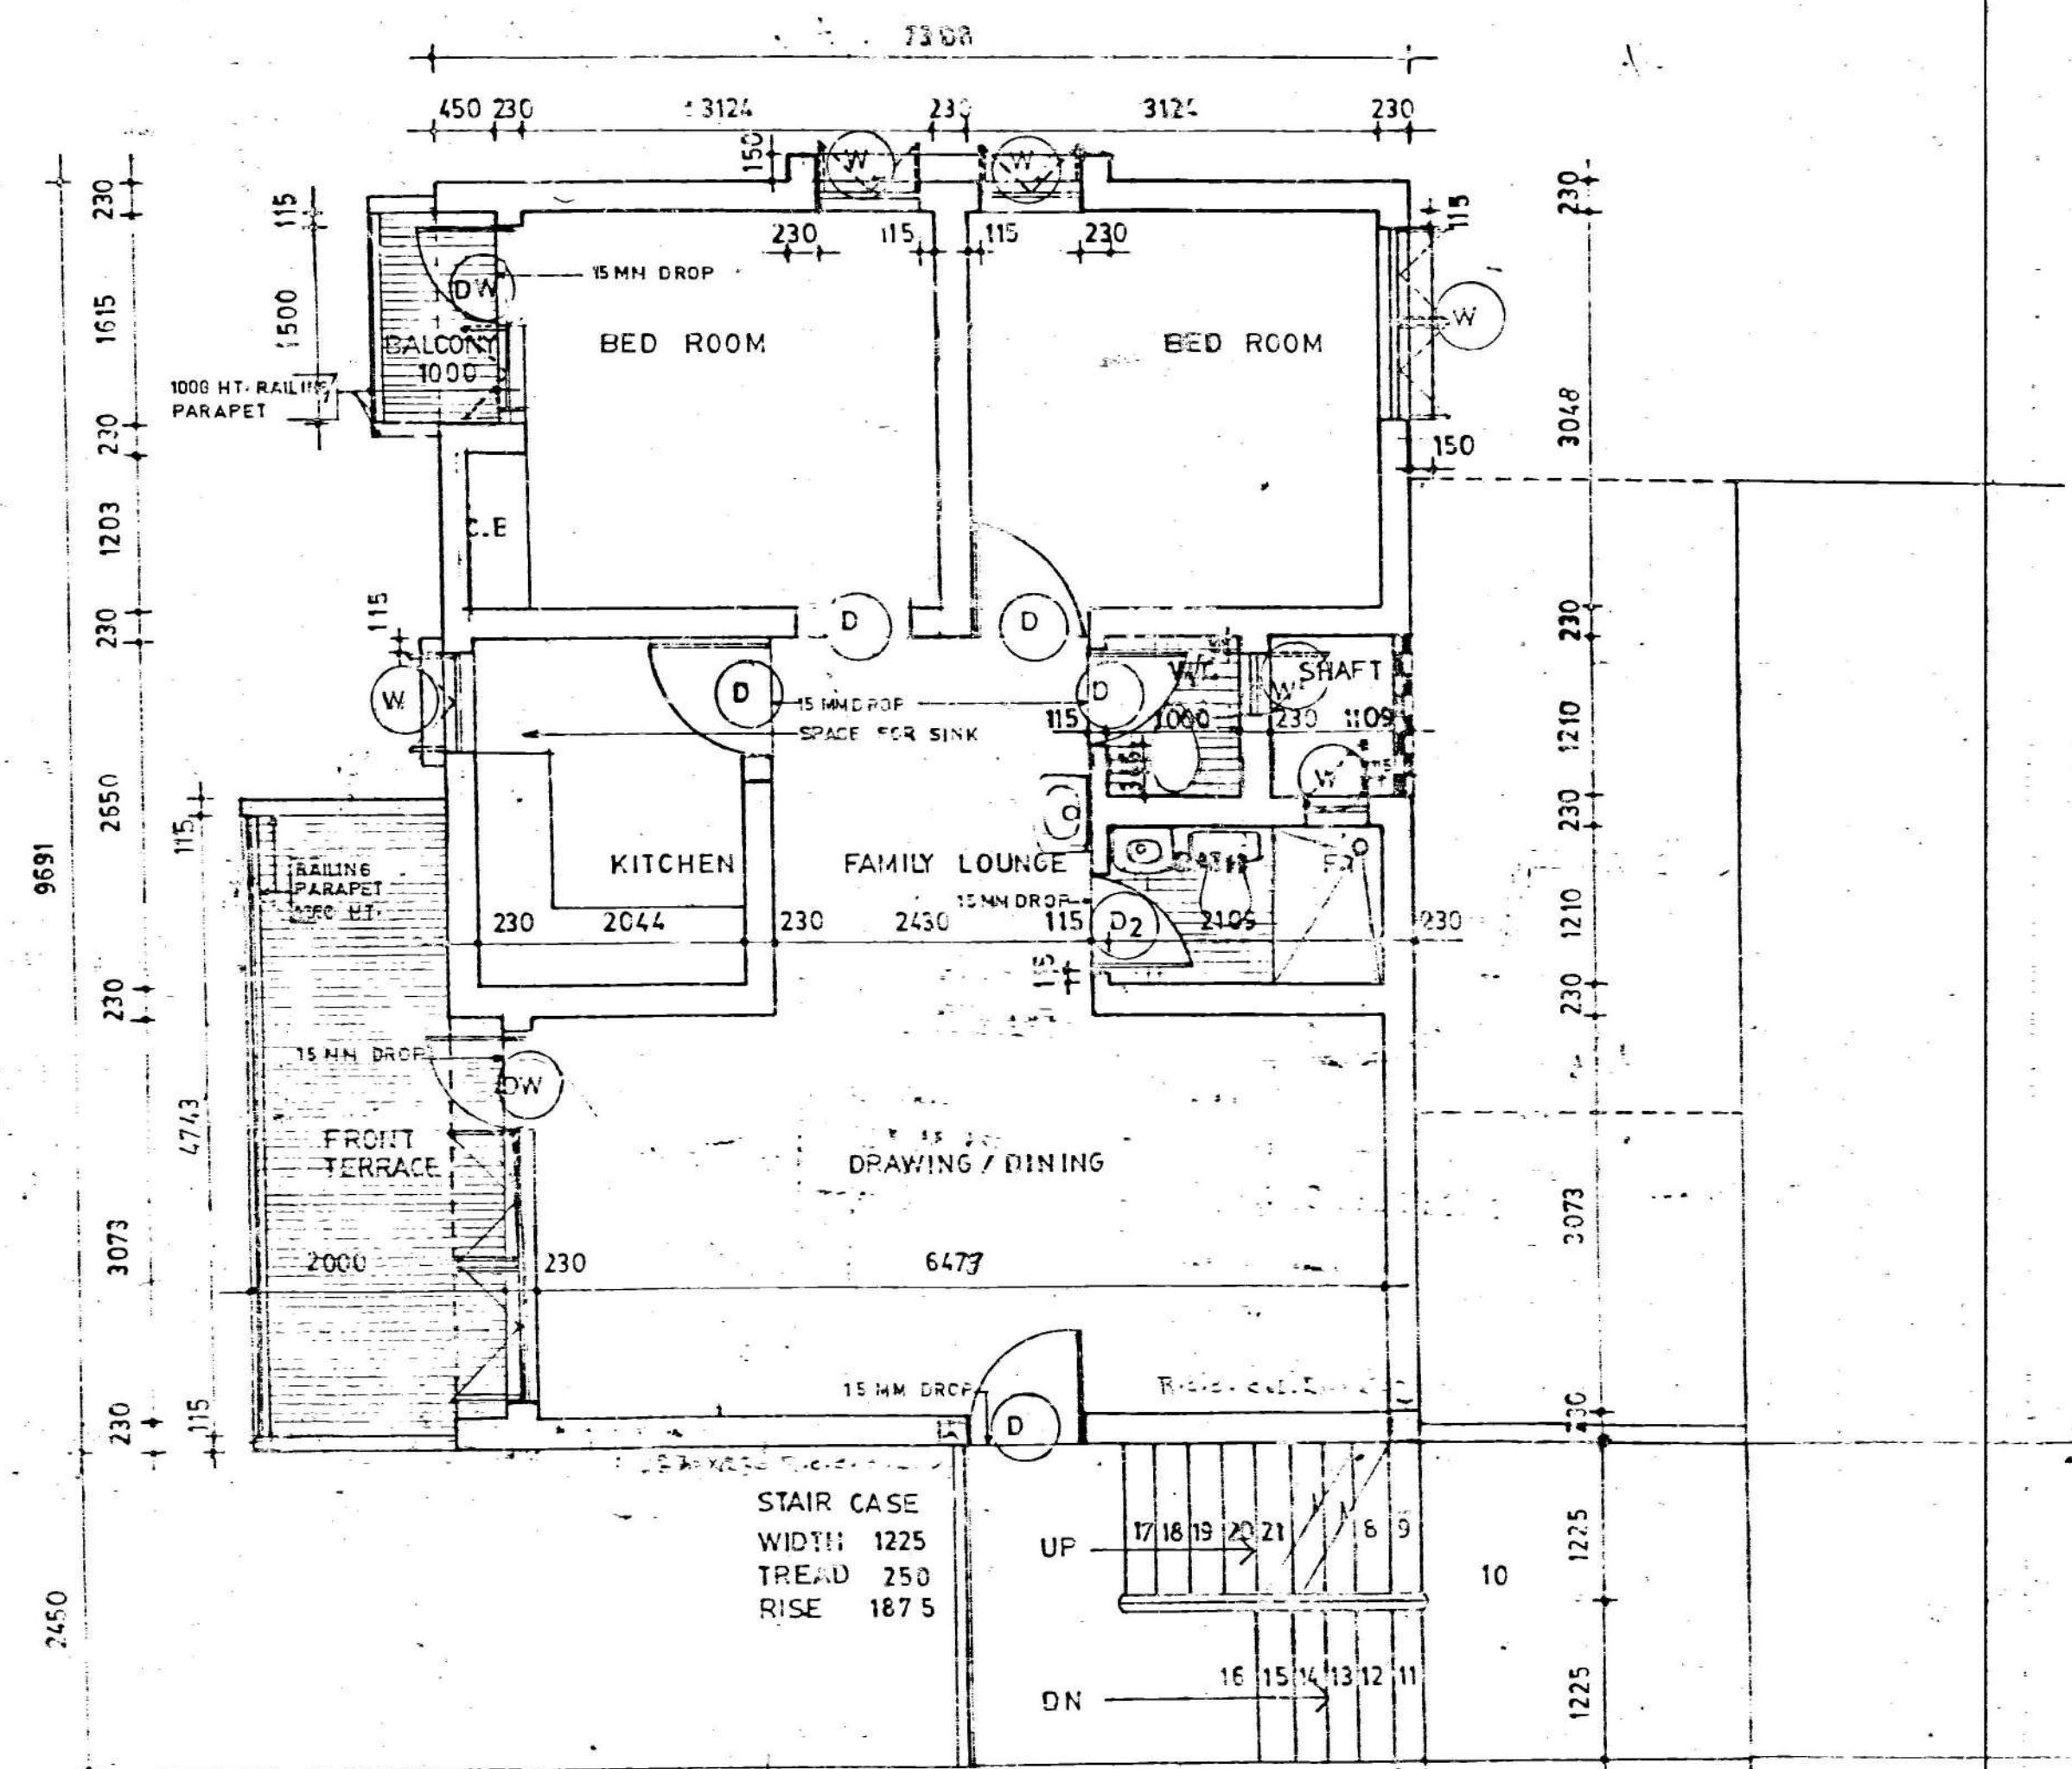

UNIT BLOCK PLAN
SCALE 1:50

NOTE: THE NUMBERING IS DONE IN SUCH A MANNER THAT THE LOWEST NOS. IN EACH BLOCK ARE GR. FLOOR NOS. FOR EXAMPLE REF. BELOW:
1,2,3 GR. FLOOR
4,5,6,7 FIRST FLOOR
8,9,10,11 SECOND FLOOR
12,13,14,15 THIRD FLOOR

NOTE :- THREE BLOCKS HAVE BEEN SHIFTED UPWARD POSITION AS PER LETTER NO. F 26(3)/AE (I)/RPD.7/59 dt. 13-1-93. FROM EE.RPD.7 (GIRAM) OLD LOCATION OF BLOCKS SHOWN THUS -
THE DRAWING IS GOOD FOR CONSTRUCTION AS THE FINAL FEASIBILITY REPORT WIDE LETTER NO. F 75(86)92/EE(P)/CC6/1719 dt. 10-6-93 & 24/6/93 ALONG WITH THE DRG. SUBJECT TO THE APPROVAL OF SAMPLE.

D. D. A.

ROHINI PROJECT PLANNING & DESIGN

NOTE:-

1. SCHEME APPROVED IN THE 79TH SCREENING COMMITTEE MEETING HELD ON 10-6-91 VIDE ITEM NO. 117/91.
2. OBSERVATION OF EXPERT COMMITTEE YET TO BE INCORPORATED AND MINUTES AWAITED 16-9-91.
3. SCHEME APPROVED IN THE EXPERT COMMITTEE MEETING HELD ON 5-9-91 VIDE MINUTE NO. CE(P) III/G (20)93/PPA/745 DATED 26-9-91.
4. PRELIMINARY DRAWINGS FOR STRUCTURAL/INTERNAL, EXTERNAL DETAIL/ELECTRICAL DETAILS N.I.T ONLY.
5. FINAL DRAWINGS WILL BE ISSUED AFTER INCORPORATING THE ABOVE DETAILS AFTER RECEIVING THEM FROM C.E(R/S) OFFICE 18-7-91.
6. FOR UNIT DESIGN REFER SCHEME NO. R-75, 2-12-91.
7. FOR DEVELOPMENT & NUMBERING REFER DEVELOPMENT PLAN & NUMBERING PLAN 2-12-91.
8. THE NUMBERING IS DONE ON THE BASIS OF PROGRESS CHART SENT BY SE./C.C.9 VIDE HIS LETTER NO. FII/36/92/EE(P)/C9/PPA/1163 DATED 3-6-92.
9. THIS DRG. HAS BEEN CHECKED & VERIFIED FROM ORIGINAL LAY OUT PLAN & COMPOSITE PLAN.
10. THIS DRG. SHALL BE TREATED AS NUMBERING PLAN AS WELL AS LAY OUT PLAN FOR PKT.-7, SEC-23. & THIS DRG. SUPERCEDES EARLIER DRG. NO. RL-75.

S. NO.	DATE	DESCRIPTION
1	26.11.91	REVISED DRAWINGS FOR EXECUTION EXP. JOINTS R.C.C. COLS POSITION DISCUSSED IN THE MEETING WITH SE.(D) ON DATED 11-11-91 ACCORDINGLY DRG. HAVE BEEN REVISED STRUCTURAL DETAILS BE OBTAINED FROM OFFICE OF C.E.(D).
2	24-10-91	40 MM. EXPANSION JOINTS MARKED AS PER LETTER NO. CE (D) SP/II (165)9/18DA/774 DATED 16-10-91 AND DIMENSIONS REVISED ACCORDINGLY.

REVISIONS

UNIT DESIGN FOR M.I.G. HOUSES
LAY OUT PLAN, UNIT PLAN (SEC.- 21, PKT.- 7)

DATE: JUNE '93'

SCALE: 1:500
1:50

PL/D.M.G.S. (R.A.S.P.A.) 21/04/93

M. K. Jambha ARCHITECT 17/4 PLAS/TT.

SR. ARCHITECT

CHIEF ARCHITECT

RL-75/3
DRG NO.

ROHINI